

Keller

PLANNERS | ARCHITECTS | BUILDERS


FOX CITIES
 N216 State Road 55
 P.O. Box 620
 Kaukauna, WI 54130
 PHONE (920) 766-5795 /
 1-800-236-2534
 FAX (920) 766-5004

MADISON
 711 Lake Dr.
 Sun Prairie, WI 53590
 PHONE (608) 318-2336
 FAX (608) 318-2337

MILWAUKEE
 W204 N11509
 Coltondale Rd
 Germantown, WI 53022
 PHONE (262) 250-9710
 1-800-236-2534
 FAX (262) 250-9740

WAUSAU
 5605 Libac Ave
 Wausau, WI 54401
 PHONE (715) 849-3141
 FAX (715) 849-3181

www.kellerbuilds.com

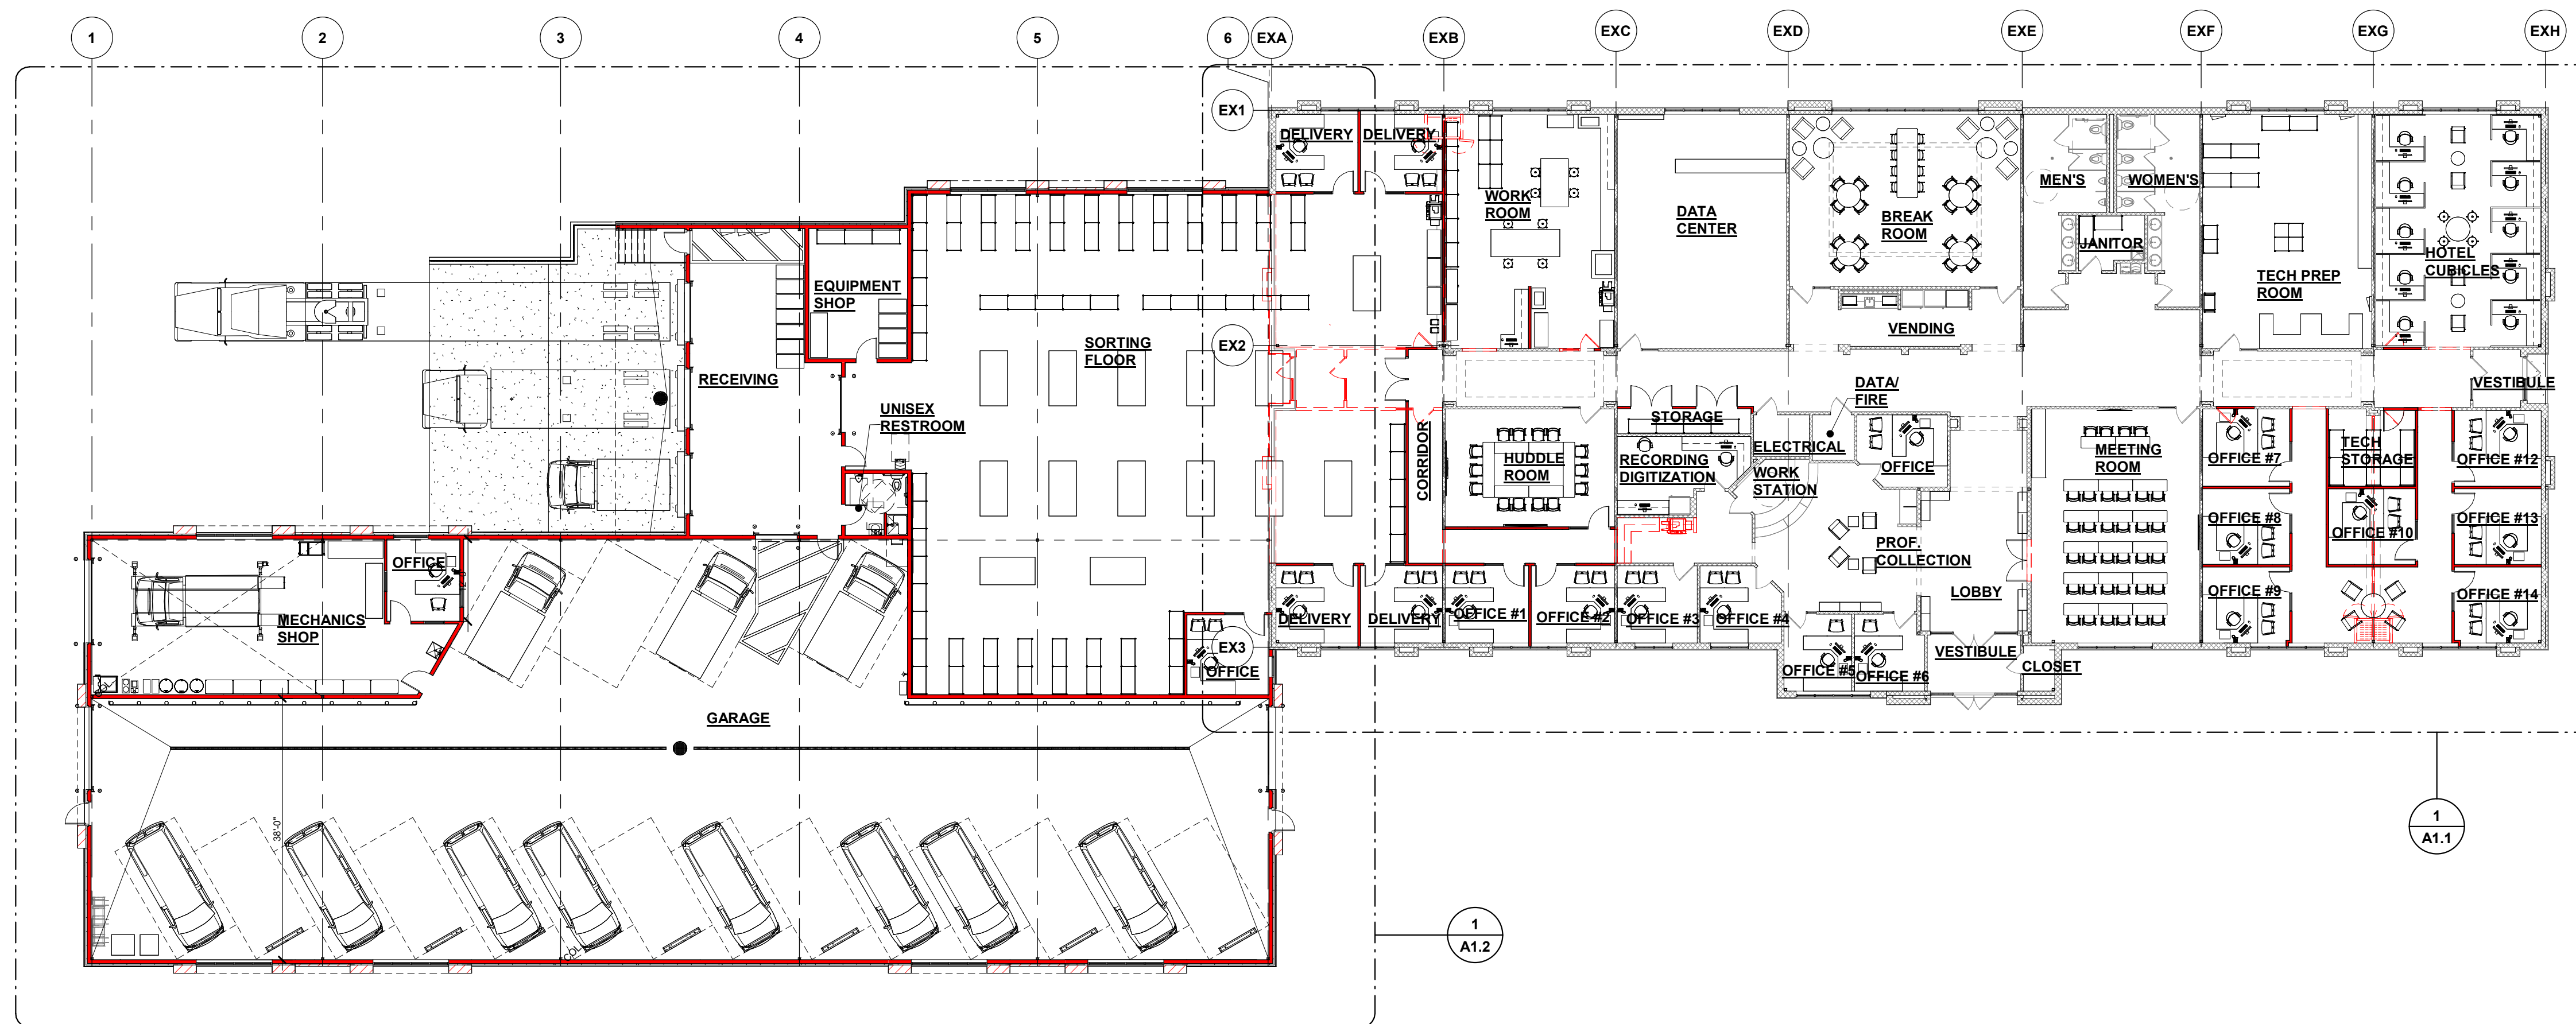

NORTH

OVERALL FLOOR PLAN
 1/16" = 1'-0"

WALL KEY	
	NEW WALL/FURRING
	NEW MASONRY/ VENEER WALL
	NEW COOLER/ FREEZER WALLS
	NEW FOUNDATION WALL
	TYPICAL EXISTING WALL
	DEMO WALLS
	FIRE WALL OR FIRE BARRIER

PROPOSED FOR:
SOUTH CENTRAL LIBRARY
 MADISON,
 WISCONSIN

"COPYRIGHT NOTICE"
 This design, drawing and detail is the copyrighted property of KELLER, INC. No part hereof shall be copied, duplicated, distributed, disclosed or made available to anyone without the expressed written consent of KELLER, INC.

PRELIMINARY - NOT FOR CONSTRUCTION

REVISIONS		
1	10/17/2022	KRW
2	11/02/2022	KRW
3	11/17/2022	KRW
4	11.28.2022	ACM
5		
6		

PROJECT MANAGER:
 D. FLANIGAN

DESIGNER:
 R. LINDSTROM

DRAWN BY:
 KRW

EXPEDITOR:

SUPERVISOR:

PRELIMINARY NO:
 P21289

CONTRACT NO:

DATE:
 07.22.2022

SHEET:
A1.0